
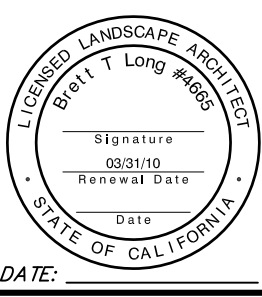


LIGHTING PLAN LEGEND


28 0.26 = FOOT CANDLES

 = LIGHT POSTS

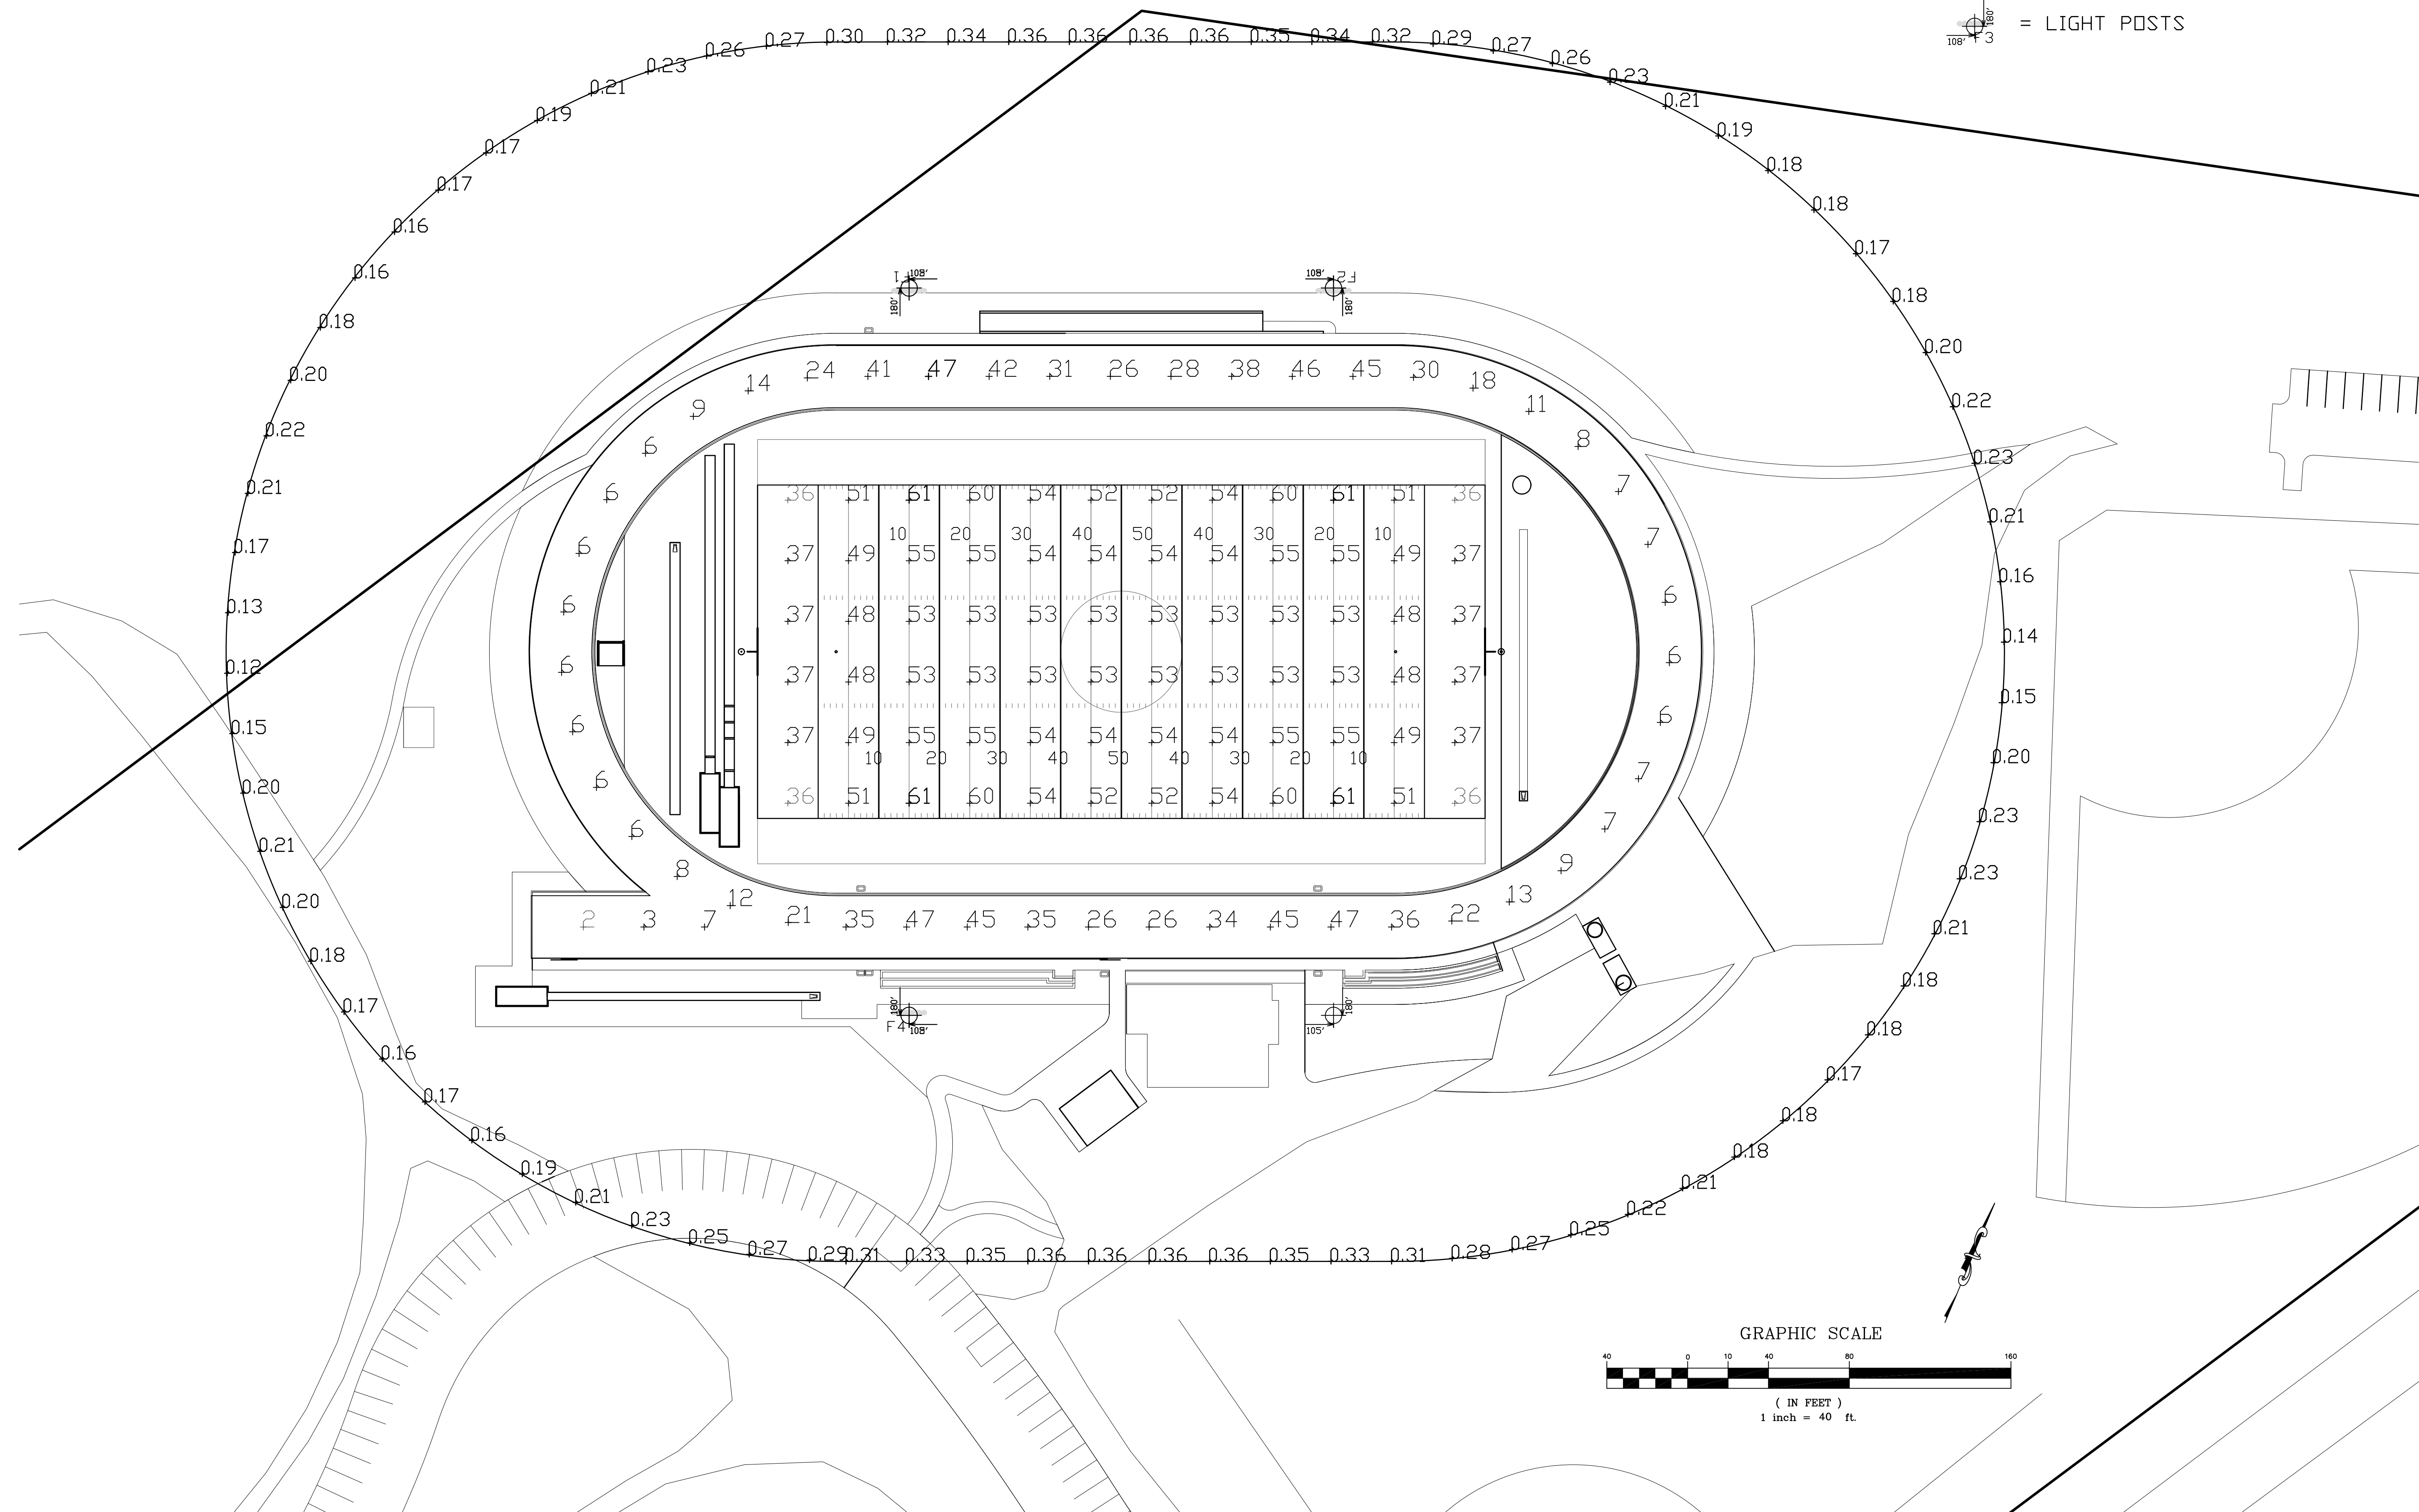

REVISIONS:	BY:

WHITMORE TRACK & SPORTS COMPLEX
SPECIAL PROJECT
 PRELIMINARY LIGHTING PLAN

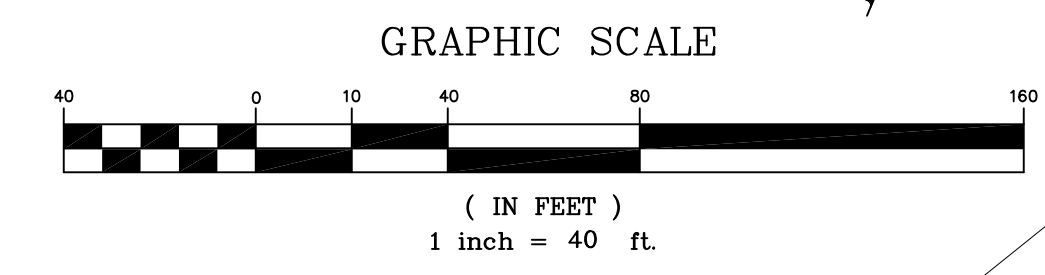

DATE: —
 SCALE: 1"=40'-0"
 DRAWN: MUSCO
 JOB NO.:
 DWG: P13
 SHEET OF